
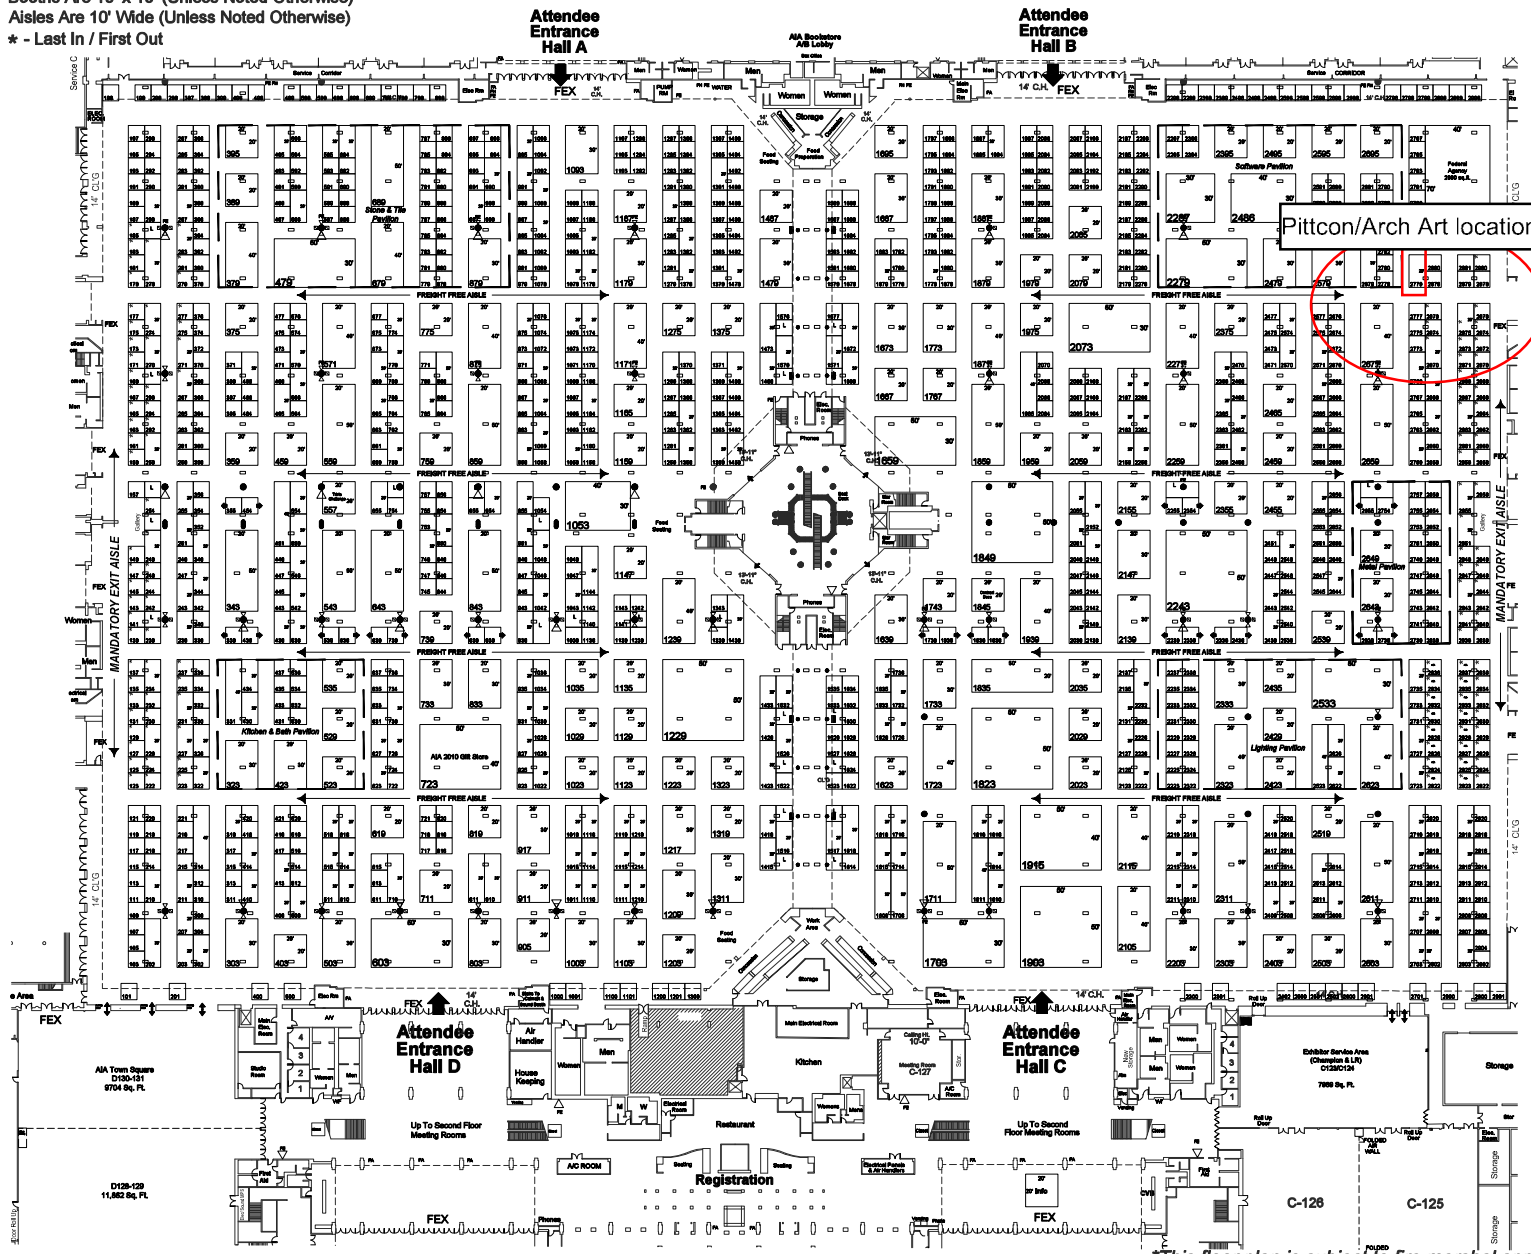


- Legend**
- Telephone available Throughout Exhibit Hall
- CEILING HEIGHT
35' Throughout Exhibit Hall Except As Indicated
- FE - Fire Extinguisher
 - FEX - Fire Exit
 - RHC - Fire Hose Cabinet
 - - 1"8" X 3"4" Electrical plumbing & Telephone Floor Box
 - - 24" Diameter Column
 - - 24" x 48" Rectangular Column
 - - 42" Diameter Column
 - - 24" X 66" Oval Columns Along East Wall Of Hall D
 - ▽ - 2" X 2" Floor Drain
 - △ - Water & Compressed Air Access On Column
- *Booths should stay min. of 1' off the columns.

Booths Are 10' x 10' (Unless Noted Otherwise)
Aisles Are 10' Wide (Unless Noted Otherwise)
* - Last In / First Out

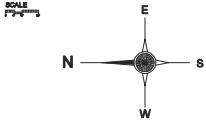

Pittcon/Arch Art location 2779

*This floor plan is subject to fire marshal approval.

Disclaimer: The information contained in this document is for informational purposes only and does not constitute an offer of insurance or any other financial product. The information is not intended to be used as a basis for any investment decision. The information is not intended to be used as a basis for any investment decision. The information is not intended to be used as a basis for any investment decision.

The American Institute of Architects
June 10 - 12, 2010
Miami Beach Convention Center, Miami, FL
Level 1

Account Executive: Jimmy Burr
Revision Date: 2.26.10
Rev: # 09
Drawn by: Kelly Coulumby
Scale: Fit to Page

138 Campbell Drive
Maitland, FL 32751
Tel: 407.876.1000
Fax: 407.876.1400

